



ARCHITECTURAL GROUP
120 SANNICAN DRIVE
TRENTON, NJ 08618
Phone: 609-695-7400

SCALE:

SIGNATURE:
THOMAS D. TORINO
SCOTT E. JOHNSON
STEPHEN L. KANE
SPEIZLE ARCHITECTURAL GROUP, INC.

01.A001.004400
02.A001.074400
03.A001.074400
04.A00006.0000

CERTIFICATE:

CONSULTANTS:

PROJECT:

HVAC AND SITE
UPGRADES

FOR

SPRINGFIELD TOWNSHIP
BOE

2146 JACKSONVILLE-JOBSTOWN
ROAD, JOBSTOWN, NJ 08041

SUBMISSION DATES:

FOR CODE REVIEW:

REVISIONS:

FOR BID: 02-15-16

DRAWING TITLE:

1964 WING TOILETS
AND ROOM 7B


COMMISSION NUMBER:

15K023

DO NOT SCALE THE DRAWINGS

DRAWING NUMBER:

RFQ

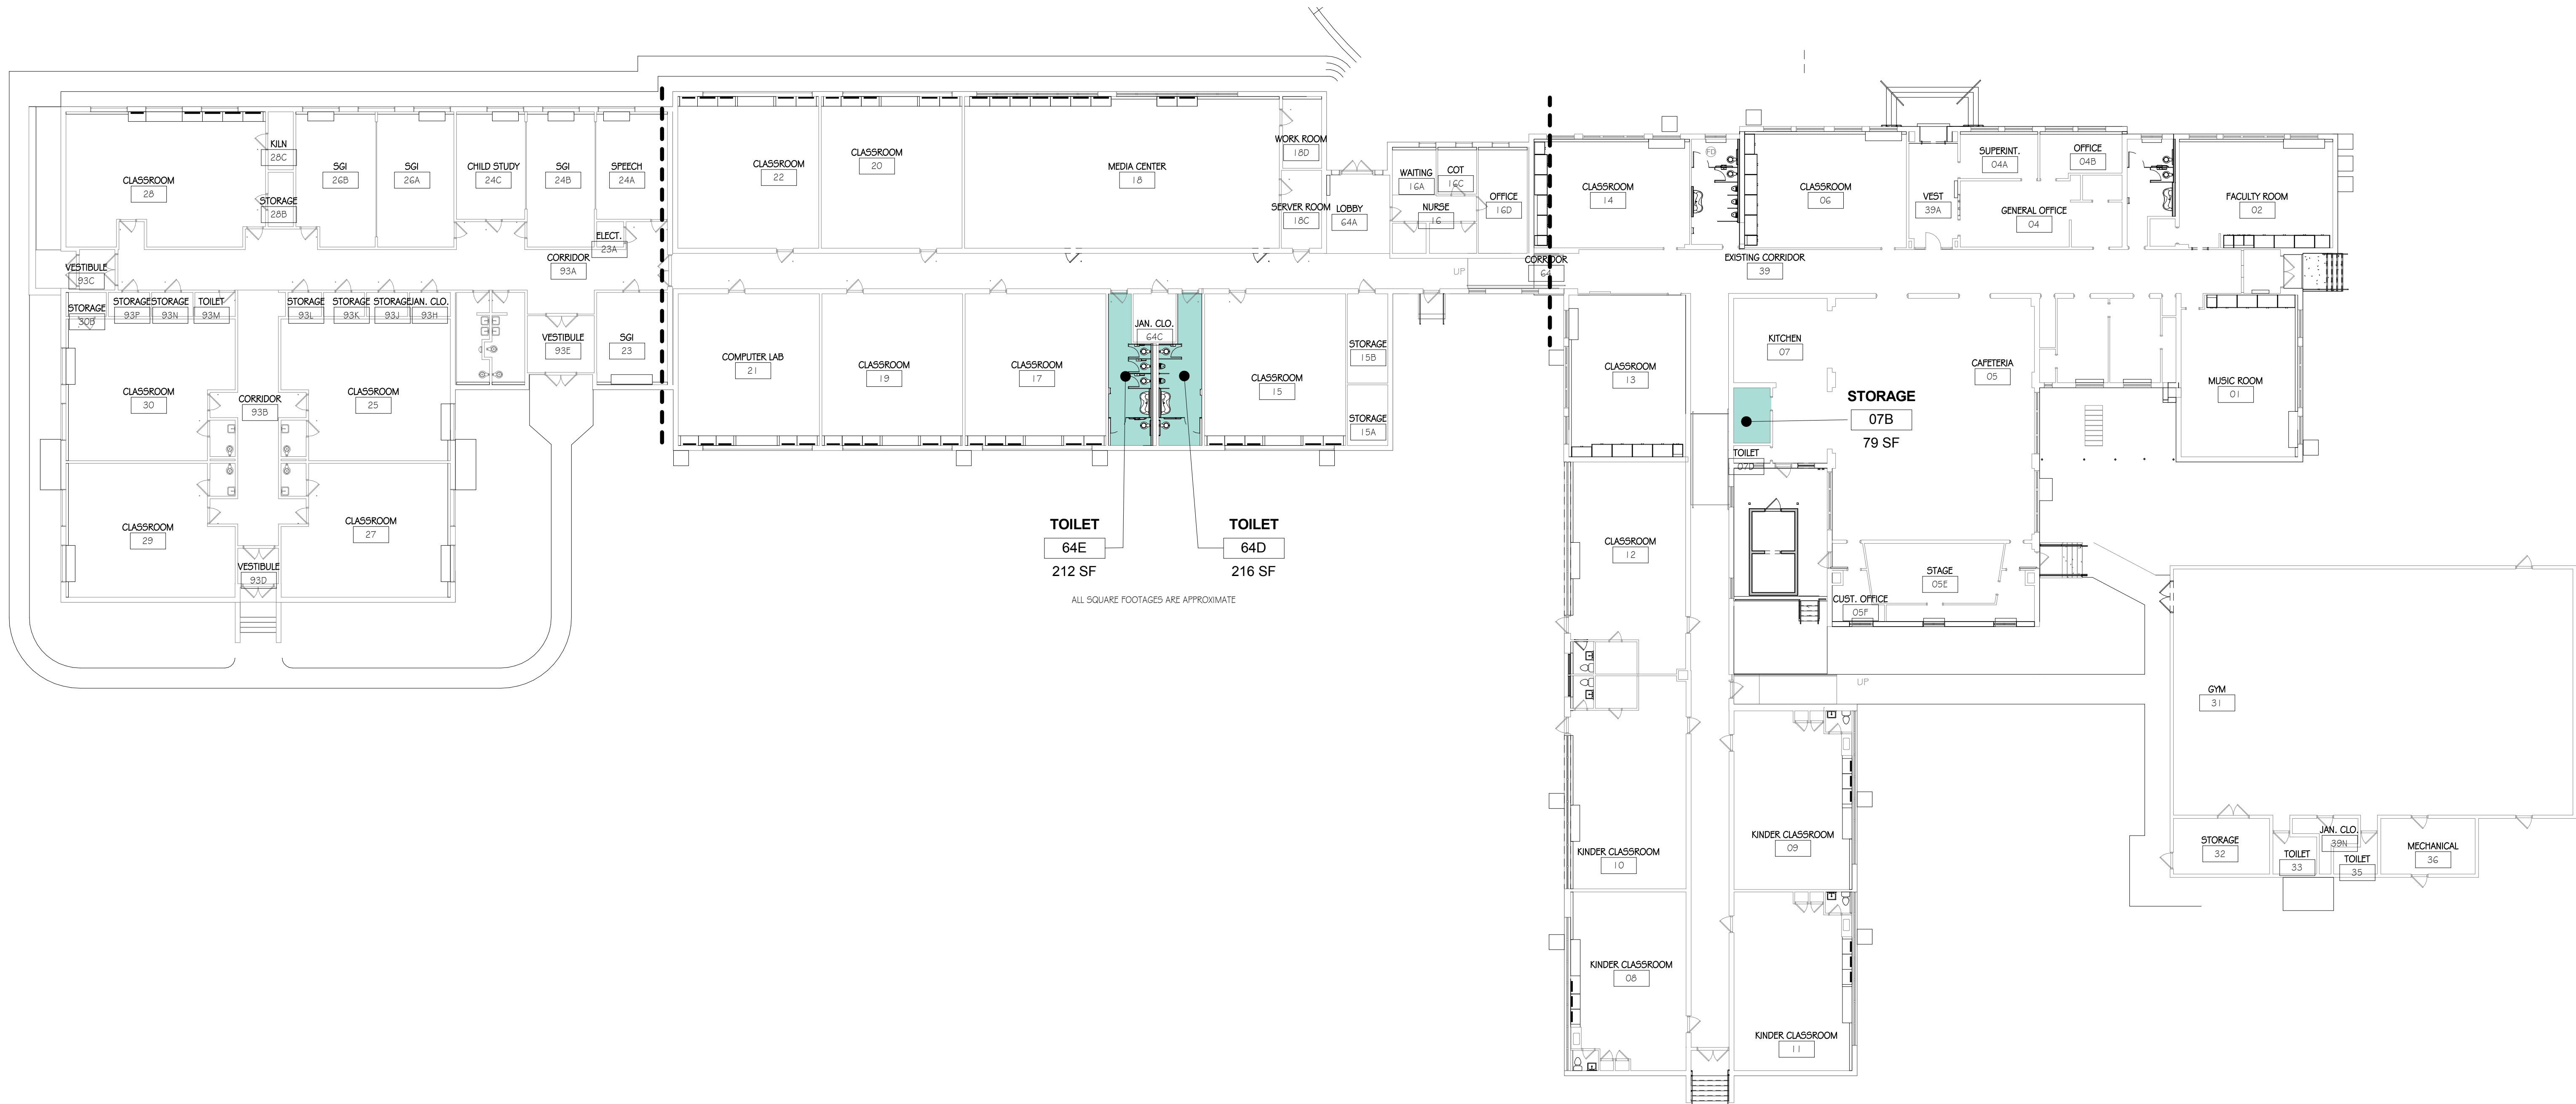

TOILET
64E
212 SF

TOILET
64D
216 SF

ALL SQUARE FOOTAGES ARE APPROXIMATE

1 PROPOSED FLOOR PLAN Copy 1
1/16" = 1'-0"